


CITY OF KALAMAZOO

WATER RECLAMATION PLANT: FINAL SETTLING TANK LAUNDER COVERS


INDEX OF PLANS

C001	COVER SHEET
C002	WATER RECLAMATION PLANT - SITE PLAN
C003	FINAL SETTLING TANKS - LAUNDER COVERS

CITY OF KALAMAZOO
 KALAMAZOO COUNTY, MICHIGAN
 WATER RECLAMATION PLANT:
 FINAL SETTLING TANK LAUNDER COVERS
 COVER SHEET

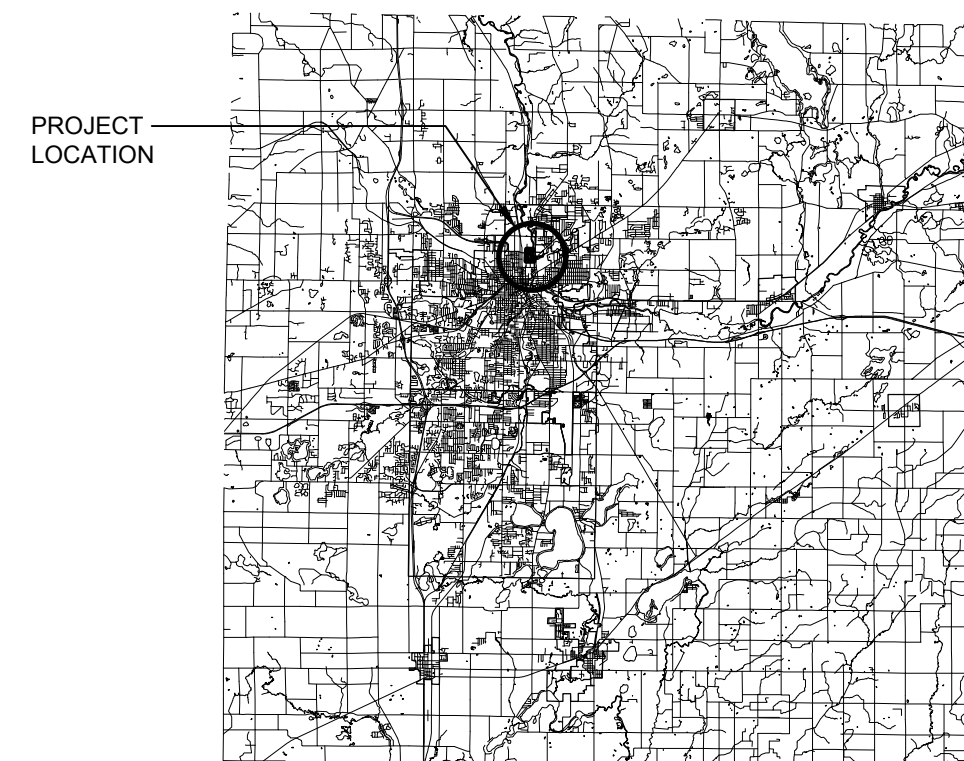

KALAMAZOO COUNTY
VICINITY MAP
SCALE: NONE

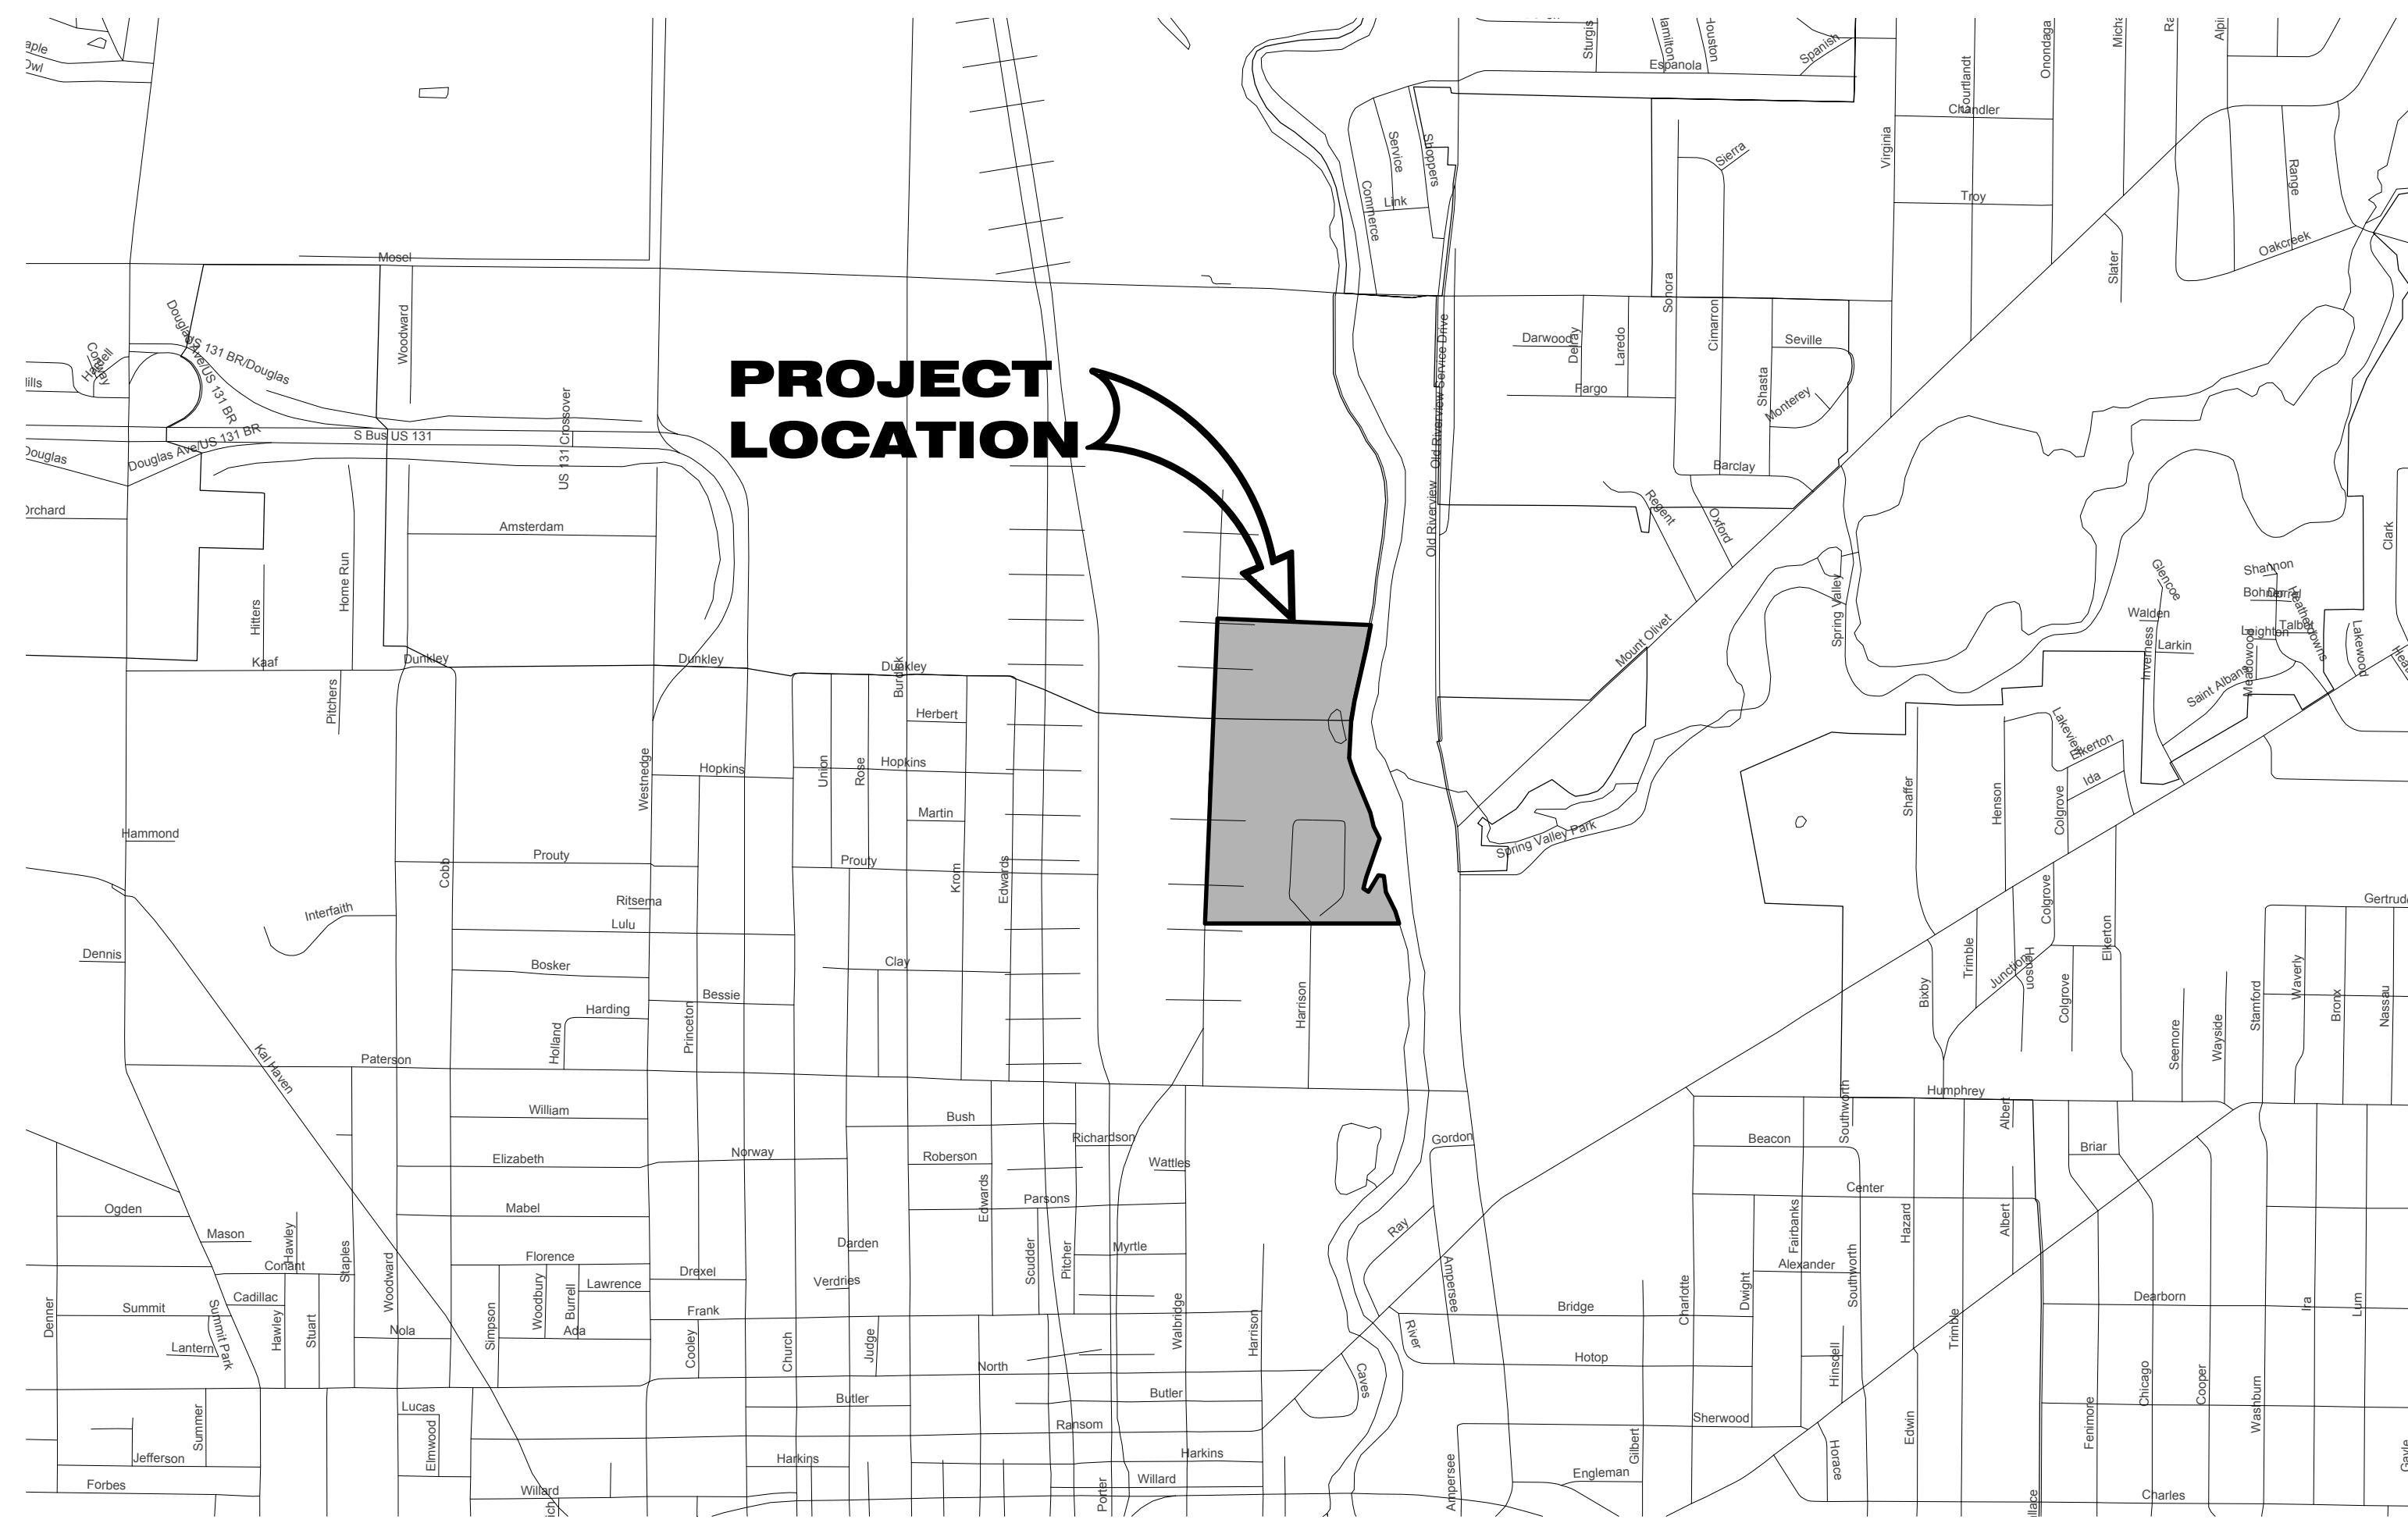

PROJECT LOCATION MAP
SCALE: NONE

UTILITIES

CABLE:	CHARTER COMMUNICATIONS 4176 COMMERCIAL AVENUE PORTAGE, MI 49002 BRYAN LONGCORE (269) 459-8746 BRYAN.LONGCORE2@CHARTER.COM COMCAST CABLE COMMUNICATIONS 25626 TELEGRAPH ROAD SOUTHFIELD, MI 48034 JEFF DOBIES (734) 359-1669 JEFF_DOBIES@CABLE.COMCAST.COM	FIBER OPTIC:	LUMEN 19675 WEST 10 MILE ROAD SOUTHFIELD, MI 48075 DAVE HUCKFELDT (517) 812-2592 DAVE.HUCKFELDT@LUMEN.COM MIDWEST COMMUNICATIONS 60590 DECATUR ROAD CASSOPOLIS, MI 49031 LARRY POWELL (269) 963-7173 LARRYMCS@VOYAGER.NET
ELECTRIC:	CONSUMERS ENERGY 2500 E. CORK STREET KALAMAZOO, MI 49001 ANDRE TAYLOR (269) 337-2245 ANDRE.TAYLOR@CSEENERGY.COM CONSUMERS ENERGY METRO 2500 E. CORK STREET KALAMAZOO, MI 49001 RYAN WALCOTT (616) 302-3041 RYAN.WALCOTT@CSEENERGY.COM	TRAFFIC:	CITY OF KALAMAZOO 415 E. STOCKBRIDGE AVENUE KALAMAZOO, MI 49001 DENNIS RANDOLPH, P.E., P.T.O.E. (269) 337-8612 RANDOLPHD@KALAMAZOOCITY.ORG
GAS:	CONSUMERS ENERGY 2500 E. CORK STREET KALAMAZOO, MI 49001 JACOB WAHLSTROM (269) 666-0707 JACOB.WAHLSTROM@CSEENERGY.COM	WATER:	CITY OF KALAMAZOO 415 E. STOCKBRIDGE AVENUE KALAMAZOO, MI 49001 DEBBIE JUNG, P.E. (269) 337-8601 JUNGDD@KALAMAZOOCITY.ORG
TELEPHONE:	AT&T 2919 MILLCORK STREET KALAMAZOO, MI 49001 PHIL BARDOCCZ (269) 384-4476 PB3132@ATT.COM	SEWER:	CITY OF KALAMAZOO 1415 NORTH HARRISON STREET KALAMAZOO, MI 49007 RYAN STOUGHTON (269) 337-8736 STOUGHTONR@KALAMAZOOCITY.ORG
PUBLIC WORKS	CITY OF KALAMAZOO 415 E. STOCKBRIDGE KALAMAZOO, MI 49001 DENNIS RANDOLPH, P.E., P.T.O.E. (269) 337-8612 RANDOLPHD@KALAMAZOOCITY.ORG		
MISS DIG	811		


00	1/16/2026	AL
	ISSUED FOR BID	
REVISIONS		
DATE:	JANUARY, 2026	
SCALE:	AS NOTED	
DRAWN BY:	M/VH	
DESIGNED BY:	M/VH	
CHECKED BY:	JMD	
PROJECT MANAGER:	AL	
JOB No.	180143	
C001		



WIGHTMAN


2303 PIPESTONE RD.
BENTON HARBOR, MI. 49022
269.927.0100

www.gowightman.com

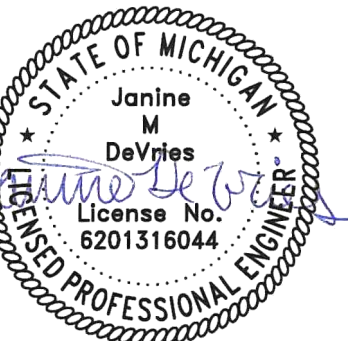

JANINE M. DEVRIES
6201316044

CITY OF KALAMAZOO
KALAMAZOO COUNTY, MICHIGAN
WATER RECLAMATION PLANT:
FINAL SETTLING TANK LAUNDER COVERS
WATER RECLAMATION PLANT - SITE PLAN

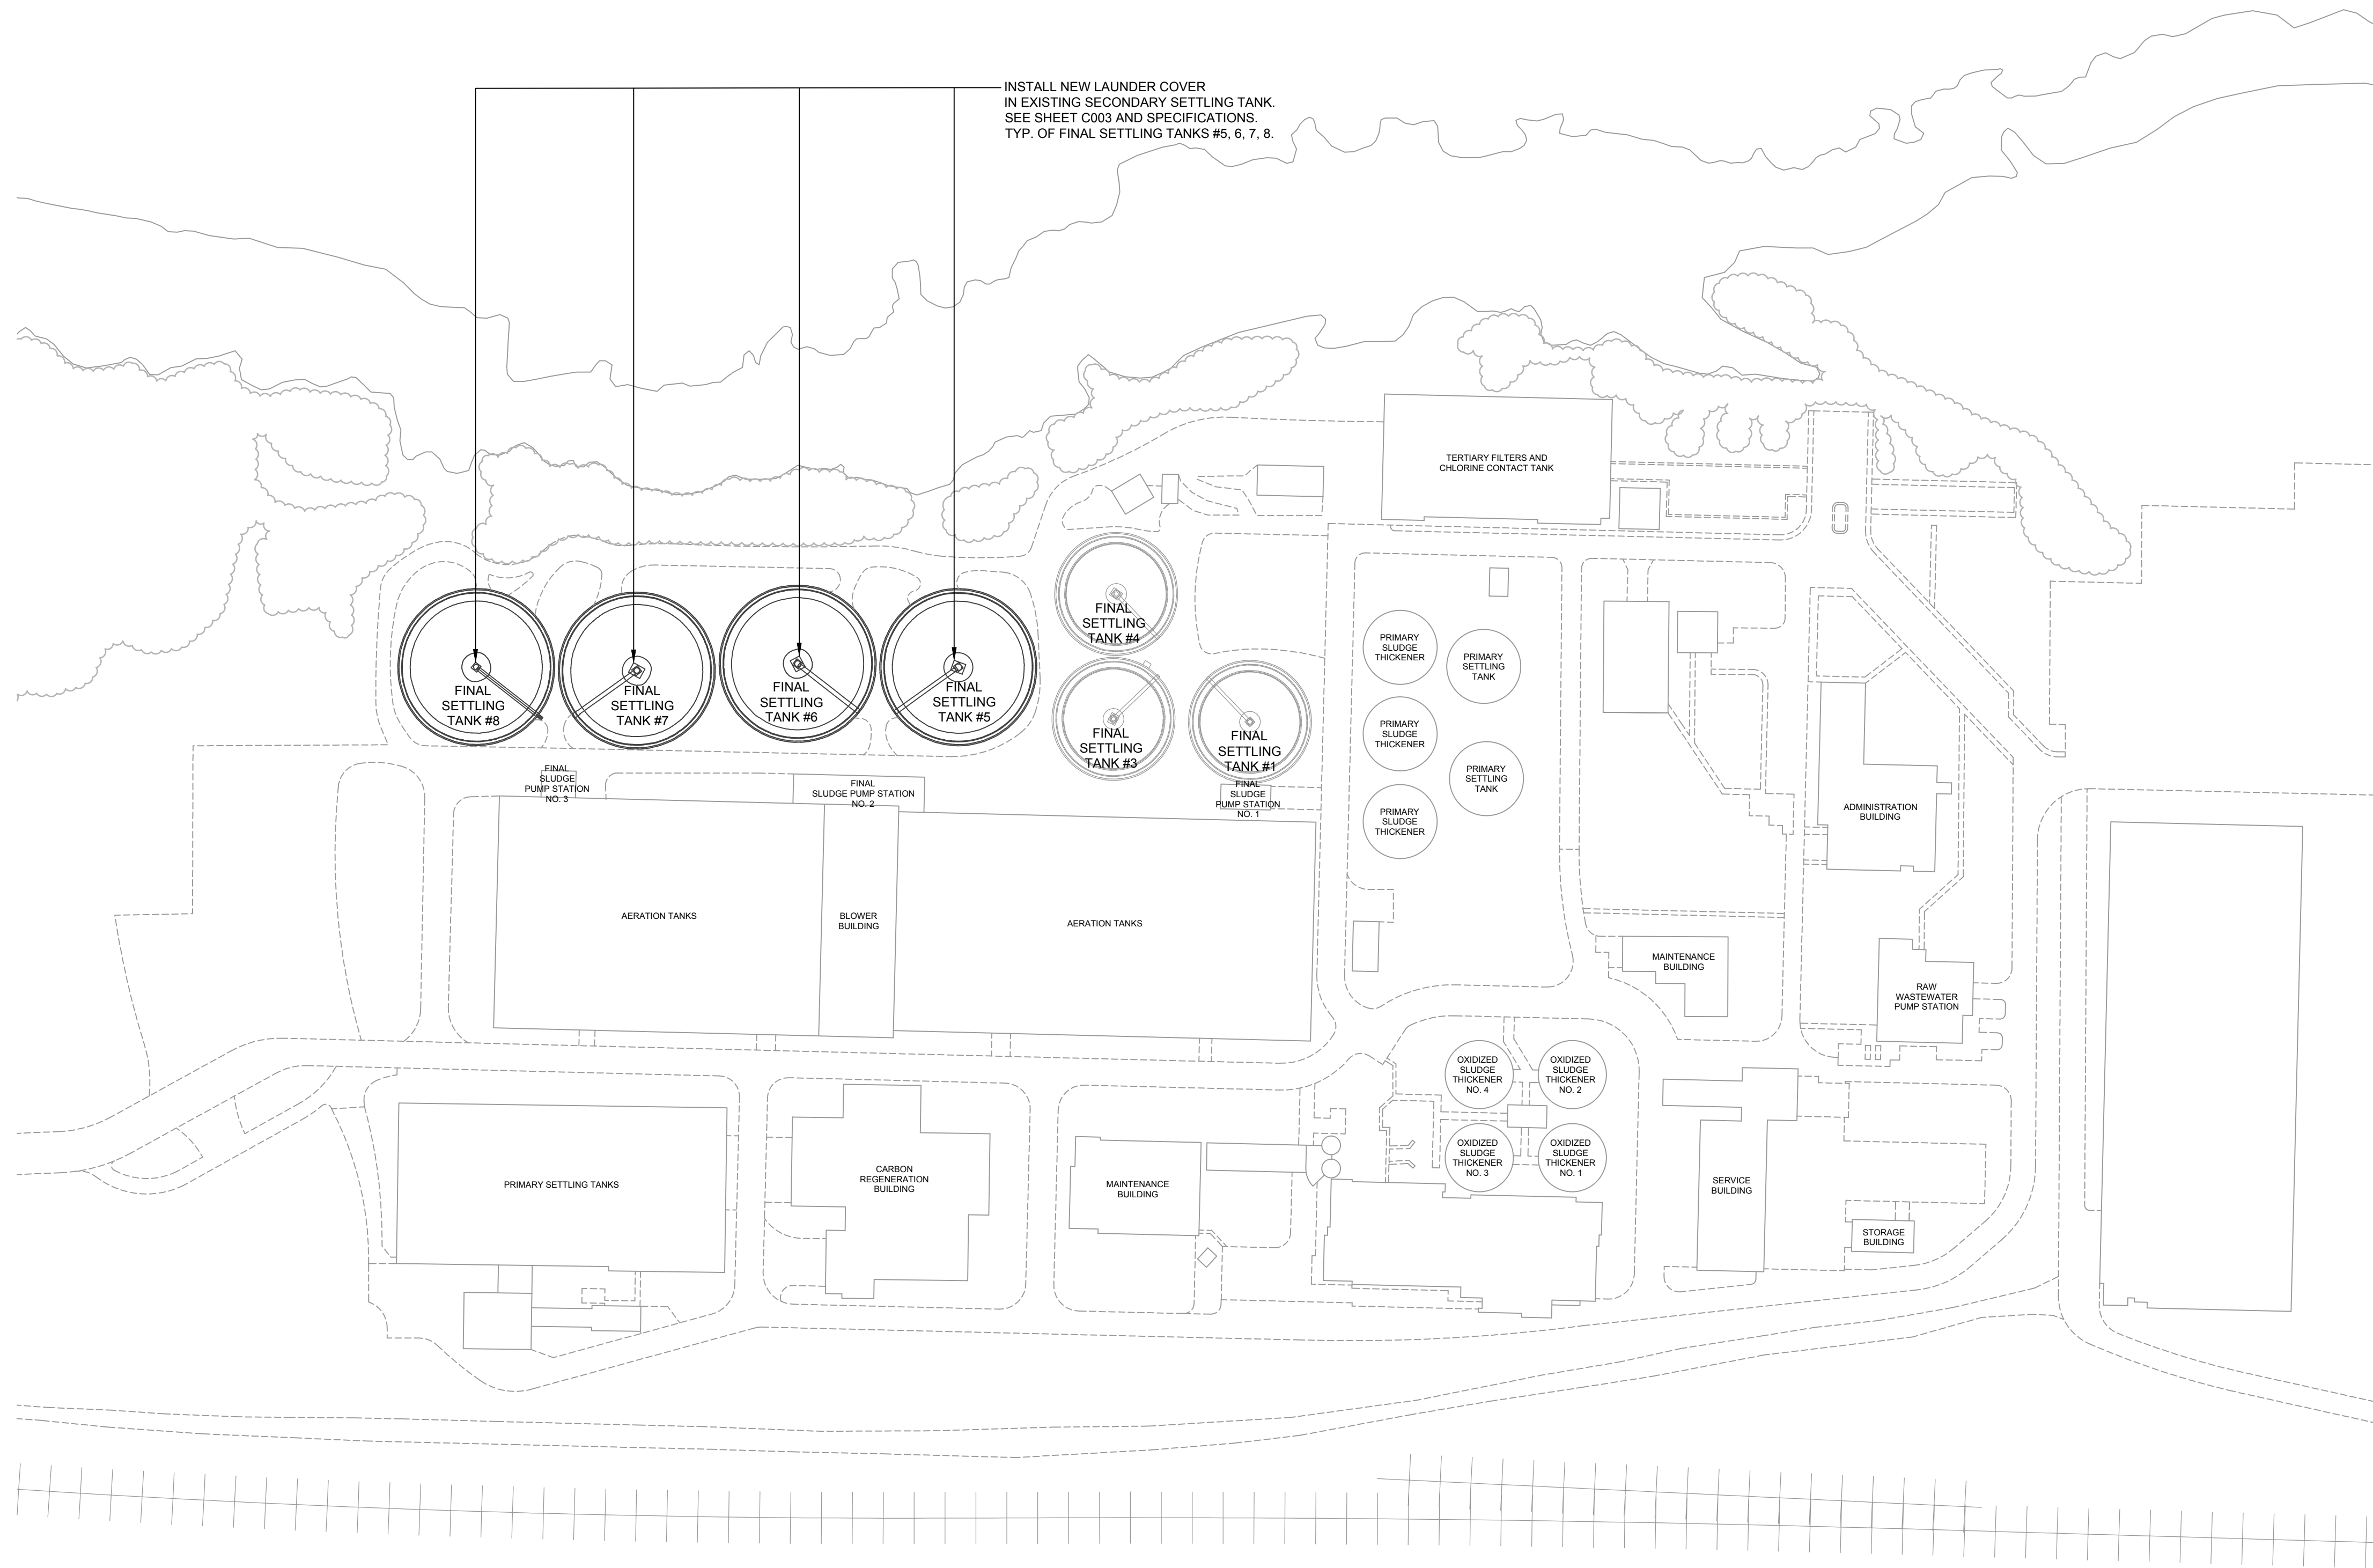


SITE PLAN
SCALE: 1" = 100'

P:\Information\161143_Kalamazoo - 91999_Civil\Water Reclamation\Project\DWG\161143-C002.dwg, 02/11/2026 11:01:52 AM

00 1/16/2026 AL
ISSUED FOR BID



REVISIONS
DATE: JANUARY, 2026
SCALE: AS NOTED
DRAWN BY: MVH
DESIGNED BY: MVH
CHECKED BY: JMD
PROJECT MANAGER: AL
JOB No. 180143

C002

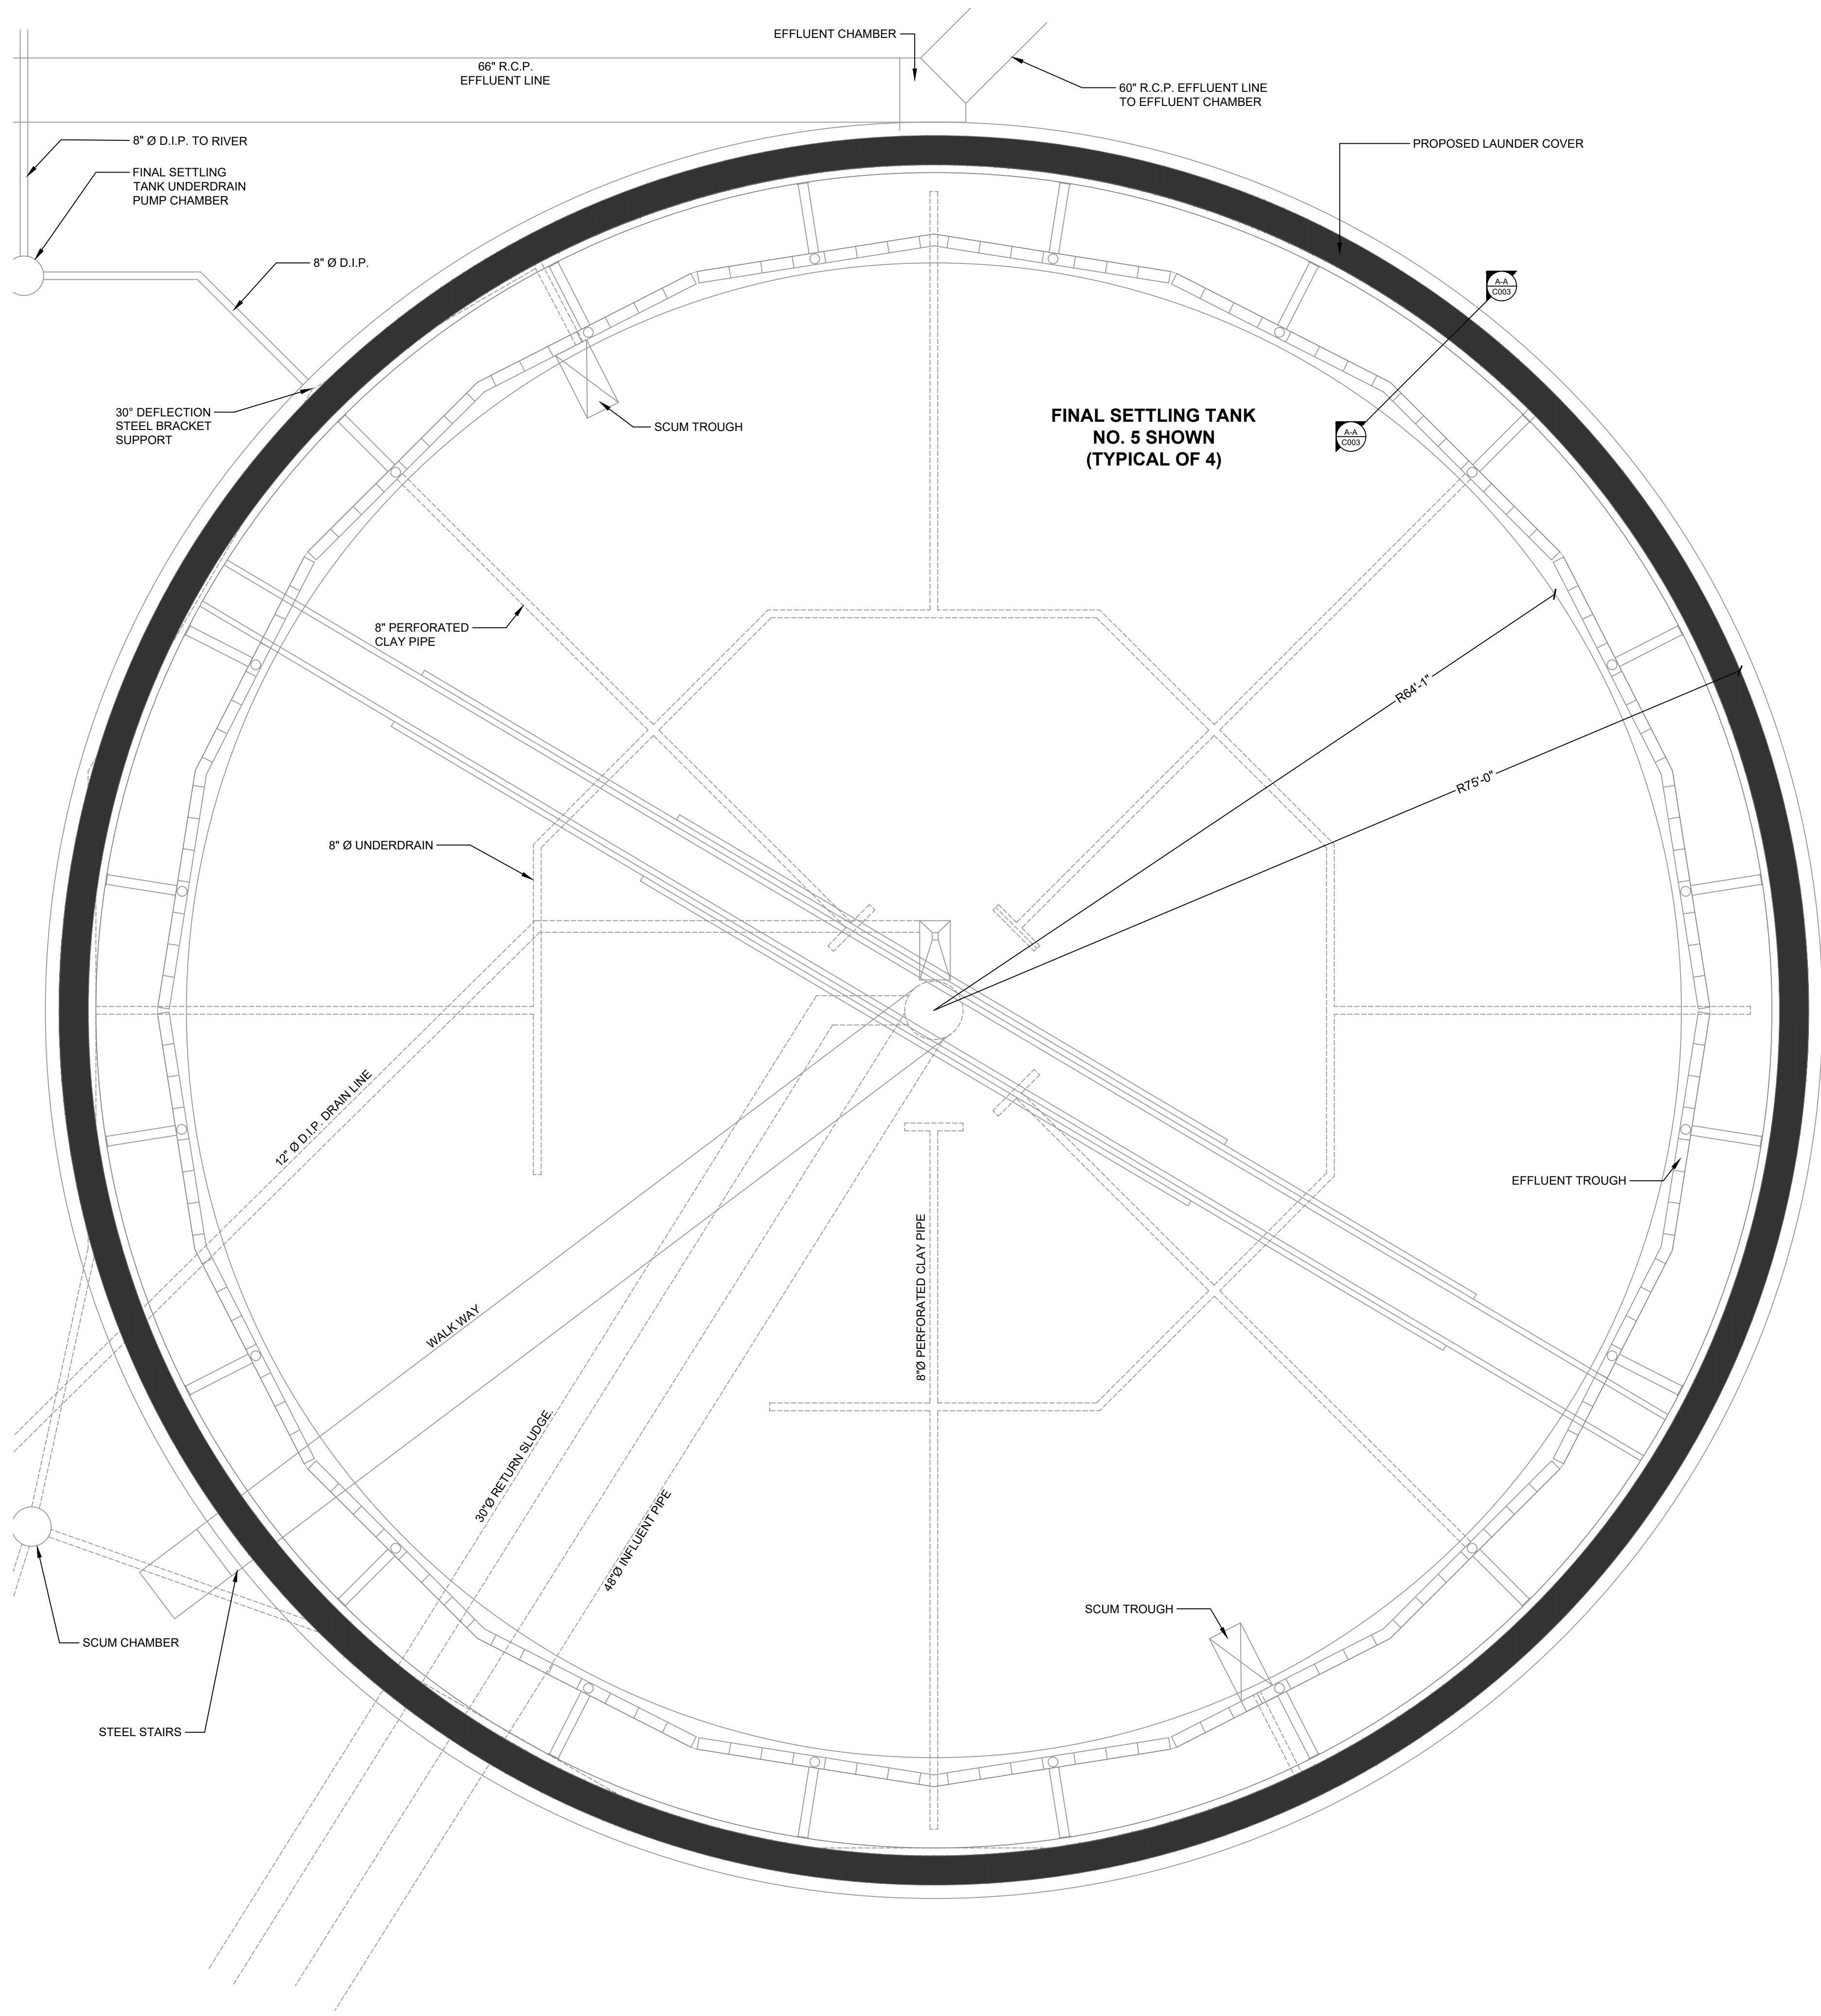

TYPICAL SECONDARY CLARIFIER

SCALE: 1/8" = 1'-0"
4 SECONDARY CLARIFIERS TOTAL

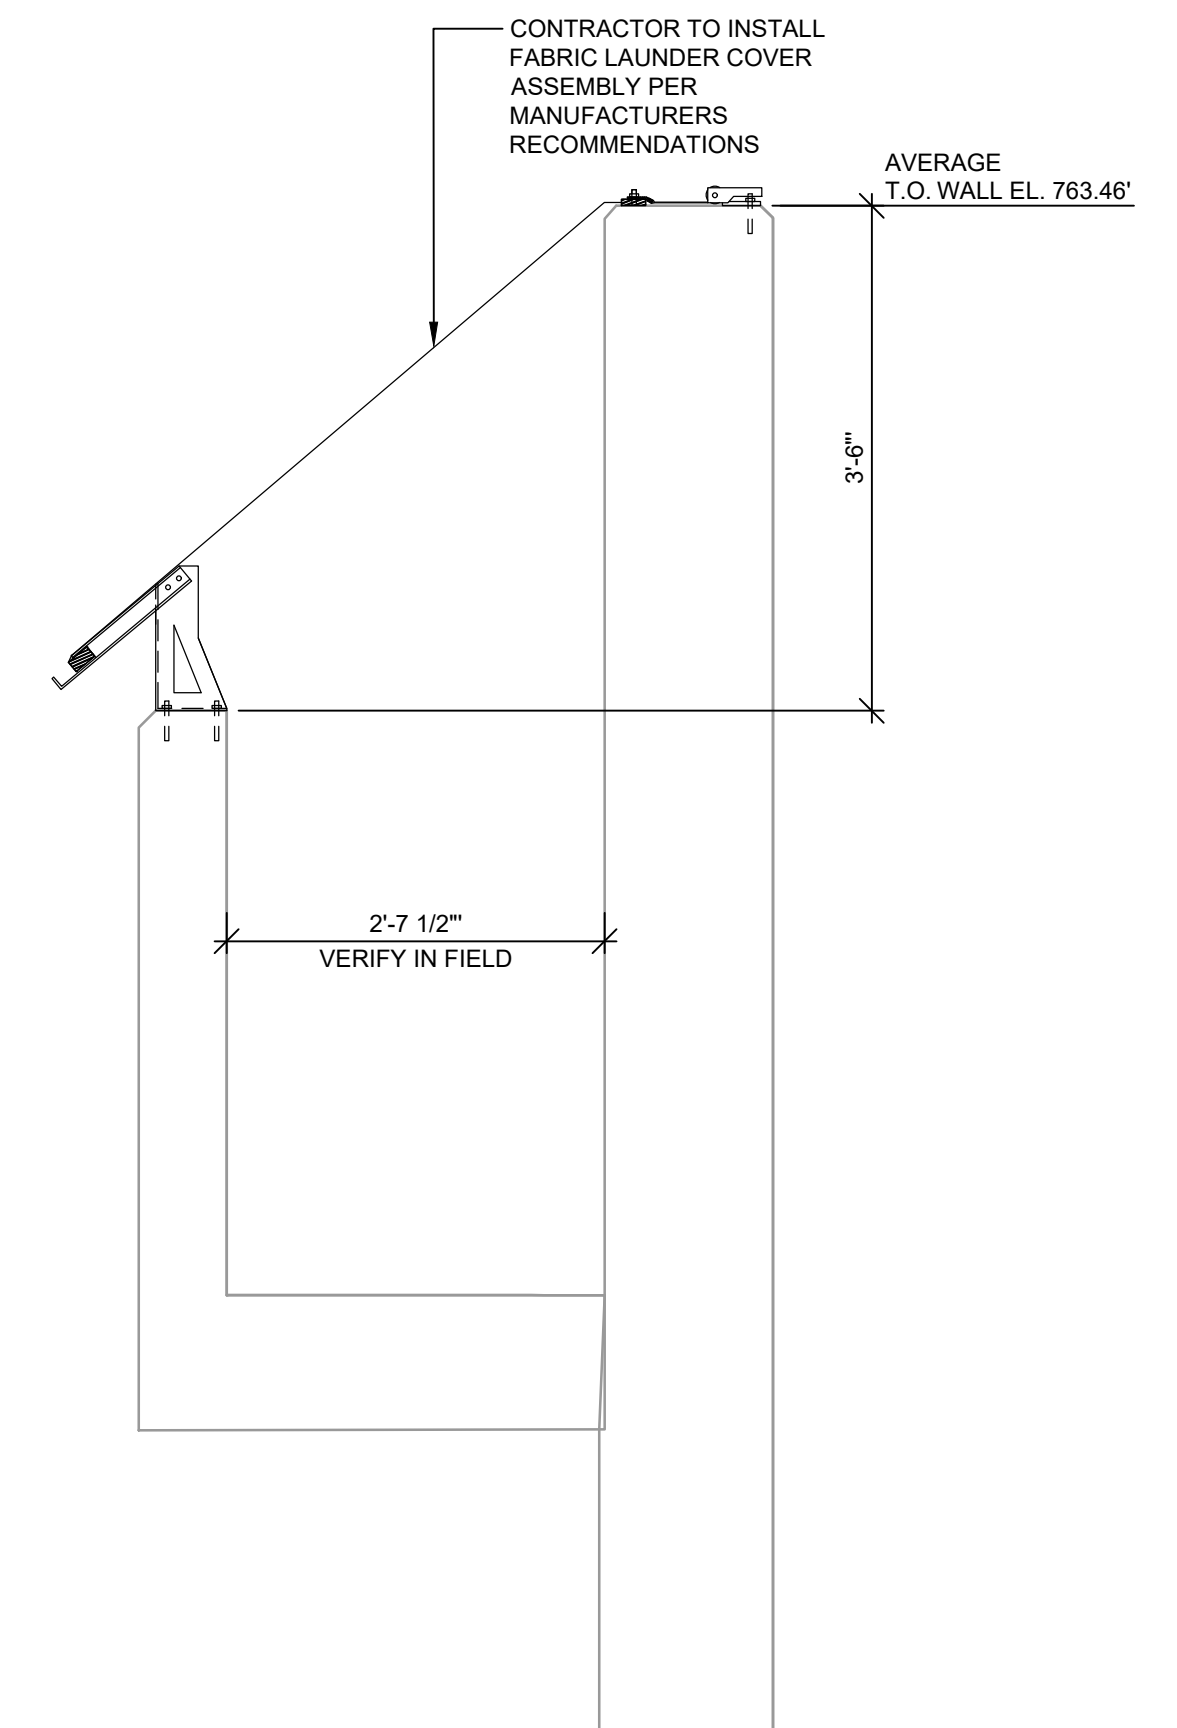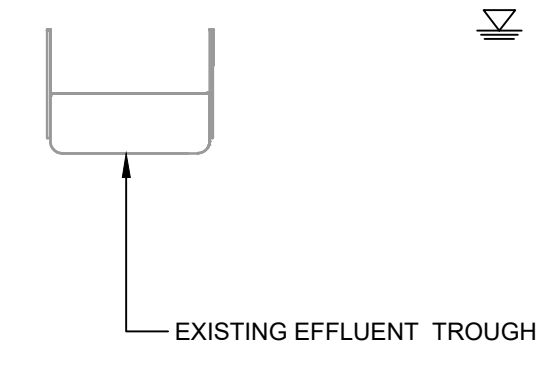

SECTION A-A
SCALE: 3/4" = 1'-0"

P:\Information\180143 Kalamazoo - 48999 Customer Reclamation Plant\Project\Drawings\180143-C003.dwg, 003 1/16/2026 3:46:55 PM